



design.reinforce@gmail.com

+690 7974477

Project:

Single Story Building HINAVAAGE

Adh.Mandhoo

Project No.:

RD-207


Client:

Adh.Mandhooo Council

Date:


16th March 2025



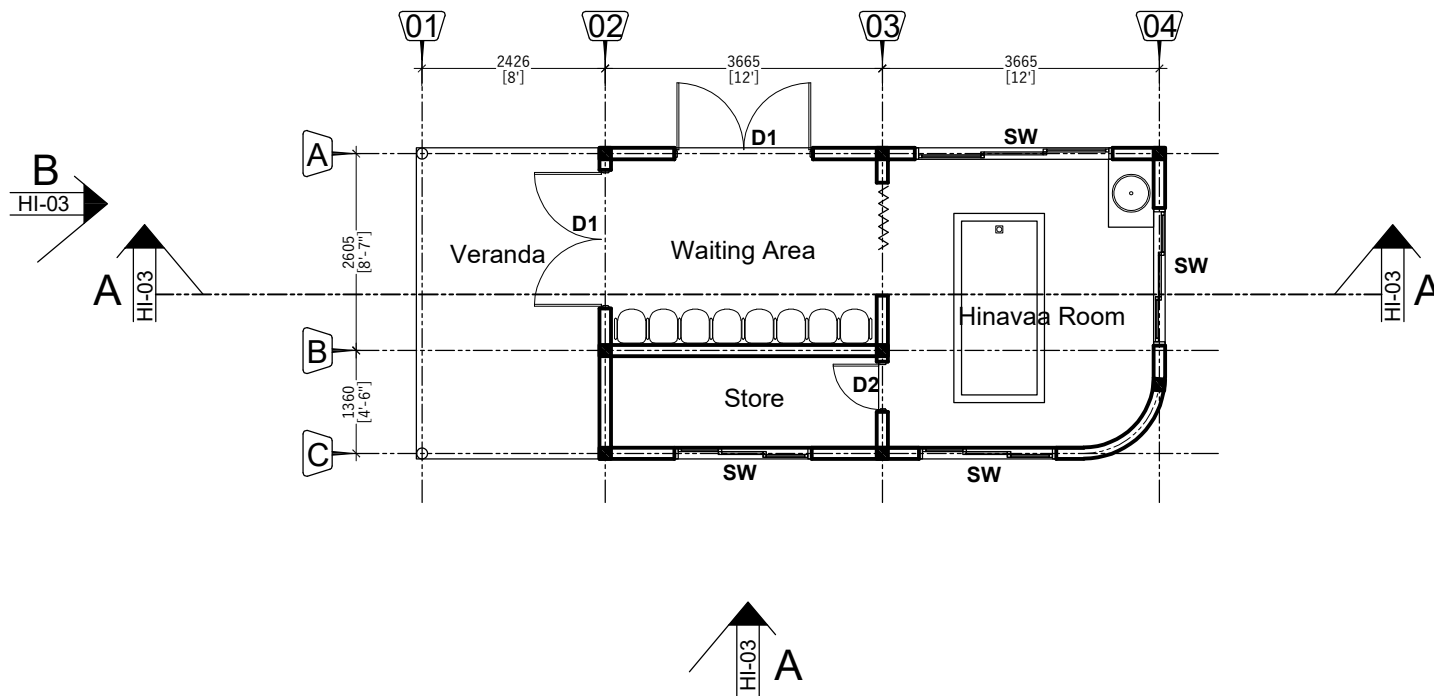

Floor Plan

Scale 1:100

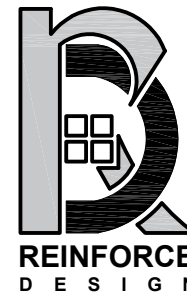

design.reinforce@gmail.com

+690 7974477

Project:
HINAVAAGE
Adh.Mandhoo

Island:
Adh.Mandhoo

Client:
Adh.Mandhoo Council

Client Contact:
+960 7791989

Architect:
Ahulam Ilyas

Engineer:
Kinaanath

Drawn By:
Assadh


Notes:

Date:
16th March 2025

Project No:
RD-207

Drawing No:

HI-01

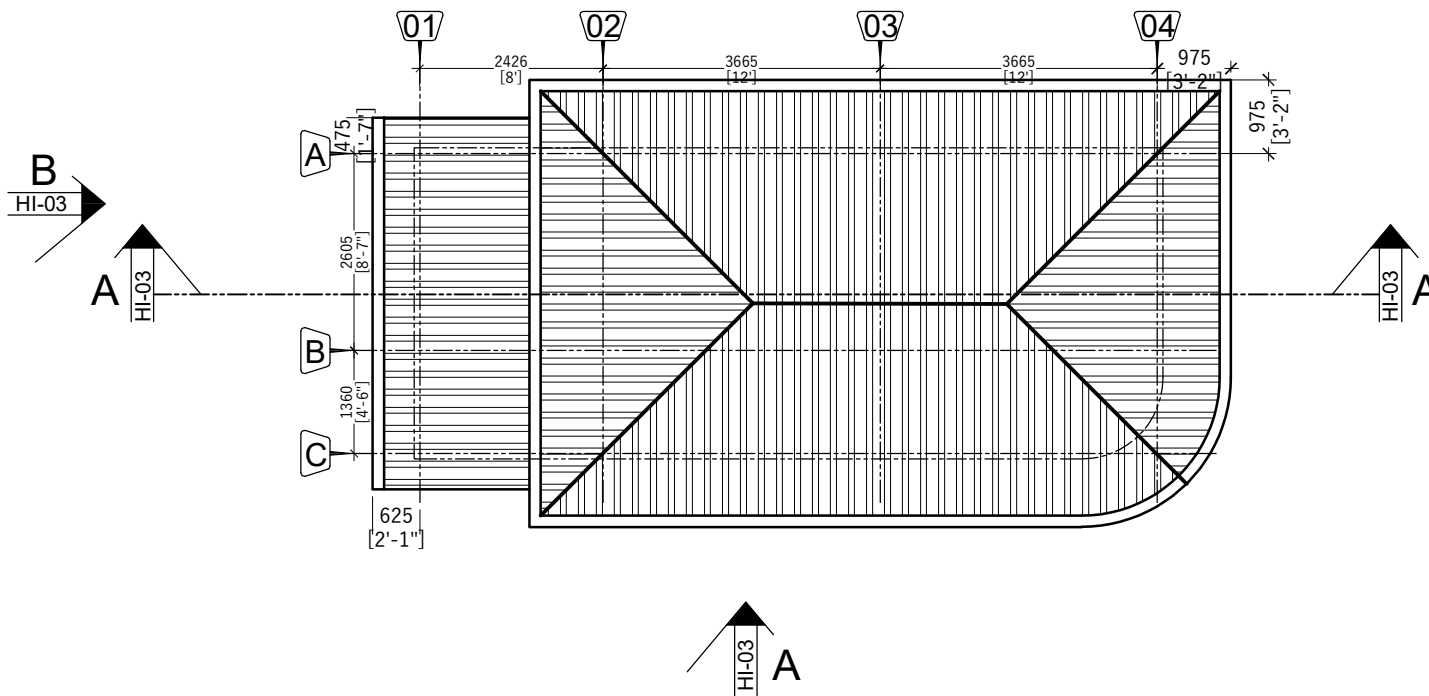

Roof Plan
Scale 1:100



design.reinforce@gmail.com

+690 7974477

Project:
HINAVAAGE
Adh.Mandhoo

Island:
Adh.Mandhoo

Client:
Adh.Mandhoo Council

Client Contact:
+960 7791989

Architect:
Ahulam Ilyas

Engineer:
Kinaanath

Drawn By:
Assadh


Notes:

Date:
16th March 2025

Project No:
RD-207


Drawing No:

HI-02

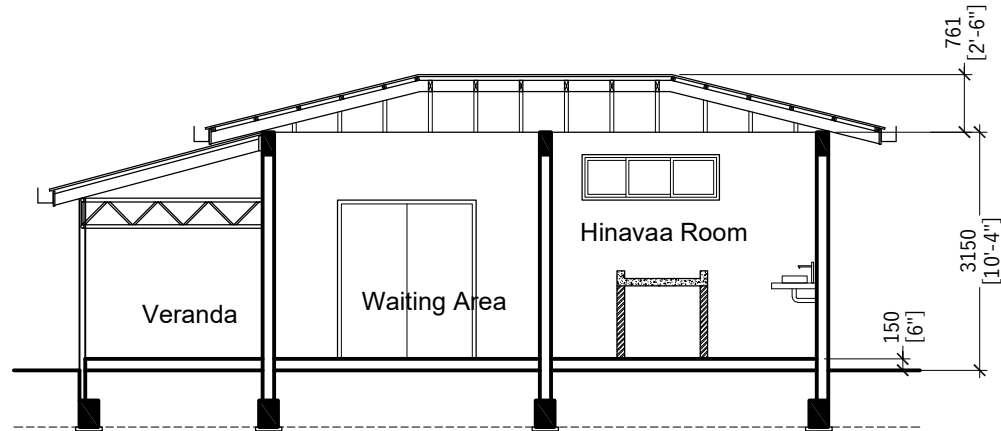


Section A-A

Scale 1:100

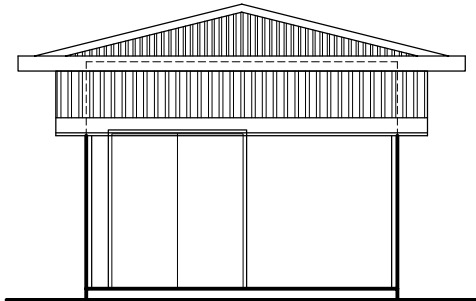

Front View - A

Scale 1:100

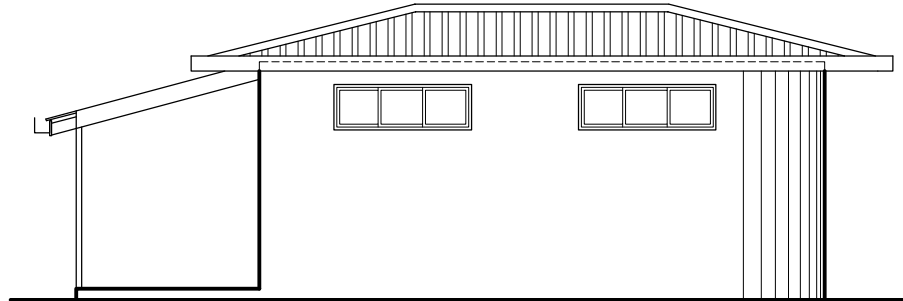

Side View - B

Scale 1:100



design.reinforce@gmail.com

+690 7974477

Project:
HINAVAAGE
Adh.Mandhoo

Island:
Adh.Mandhoo

Client:
Adh.Mandhoo Council

Client Contact:
+960 7791989

Architect:
Ahulam Ilyas

Engineer:
Kinaanath

Drawn By:
Assadh

Notes:




Date:
16th March 2025

Project No:
RD-207

Drawing No:

HI-03

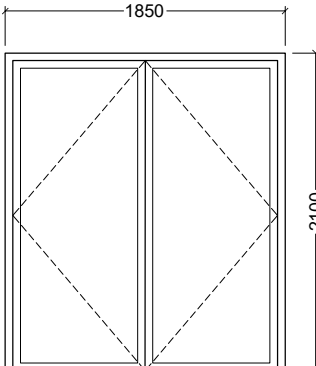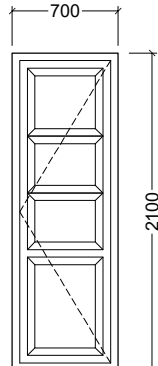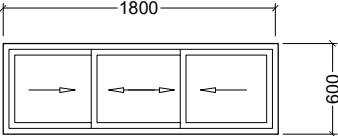

Elevations :			
Finished Floor level			
Doors & Windows mark :	D1	D2	SW1

Doors & Windows Schedule

Scale - 1:50

Note : All the measurements to be checked at site by contractor before fabrication



design.reinforce@gmail.com

+690 7974477

Project:
HINAVAAGE
Adh.Mandhoo

Island:
Adh.Mandhoo

Client:
Adh.Mandhoo Council

Client Contact:
+960 7791989

Architect:
Ahulam Ilyas

Engineer:
Kinaanath

Drawn By:
Assadh


Notes:

Date:
16th March 2025

Project No:
RD-207

Drawing No:


HI-04

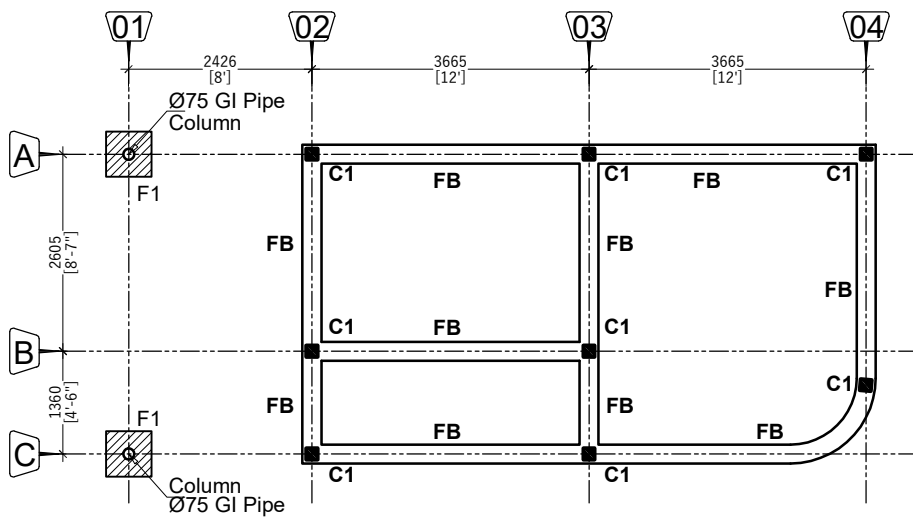

Footing Detail
F1=600X600 with T10@ 150 c/c Bottom

Foundation Layout

 
Scale 1:100



C1

(Cast along with walls)

Column Detail

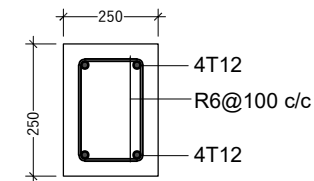

Foundation Beams Detail (FB)

Structural Details

Scale 1:20



design.reinforce@gmail.com

+690 7974477

Project:
HINAVAAGE
Adh.Mandhoo

Island:
Adh.Mandhoo

Client:
Adh.Mandhoo Council

Client Contact:
+960 7791989

Architect:
Ahulam Ilyas

Engineer:
Kinaanath

Drawn By:
Assadh


Notes:

Date:
16th March 2025

Project No:
RD-207


Drawing No:

HI-05

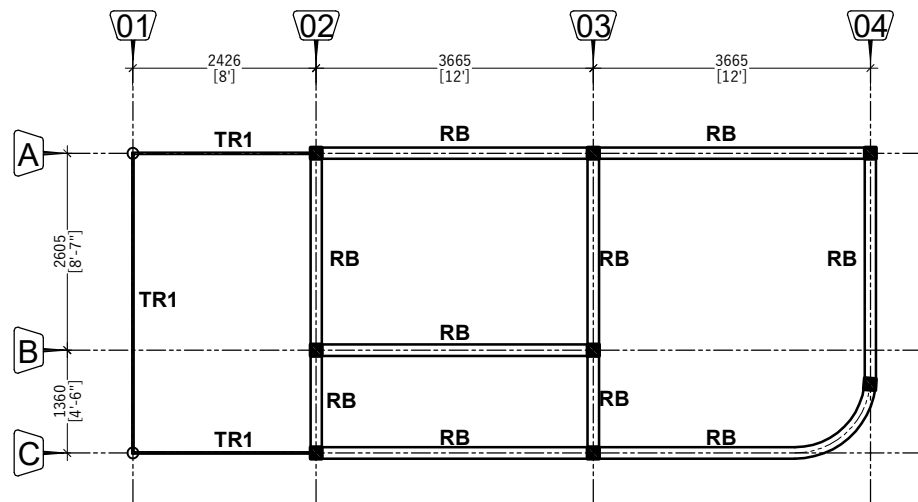



Roof Beam Layout

Scale 1:100

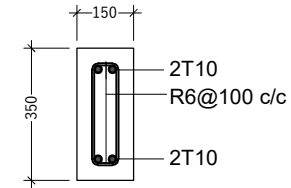

RB - CAST ON TOP OF
THE MASONRY WALL

Roof Beams Detail

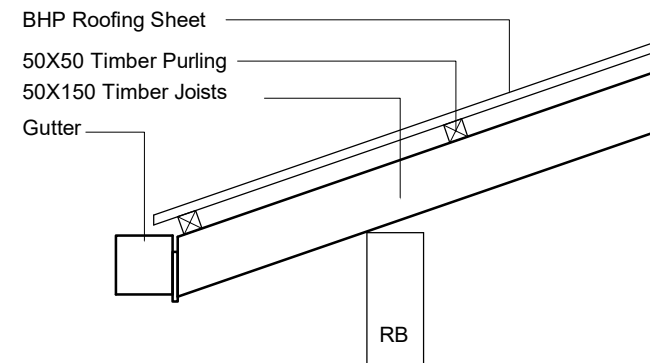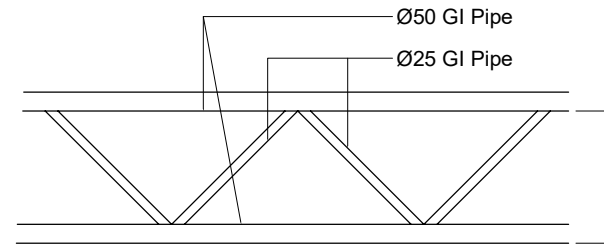

Roof Detail

Structural Details

Scale 1:20



design.reinforce@gmail.com

+690 7974477

Project:
HINAVAAGE
Adh.Mandhoo

Island:
Adh.Mandhoo

Client:
Adh.Mandhoo Council

Client Contact:
+960 7791989

Architect:
Ahulam Ilyas

Engineer:
Kinaanath

Drawn By:
Assadh


Notes:

Date:
16th March 2025

Project No:
RD-207


Drawing No:

HI-06

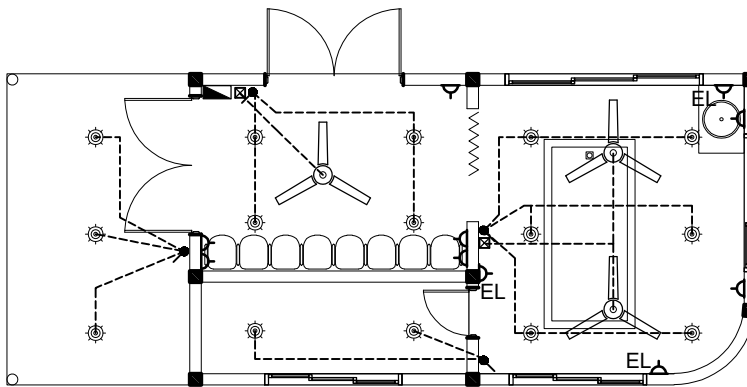

Electrical Layout

 Scale 1:100



- CEILING FAN 56"



- CEILING FAN REGULATOR @ 900MM HIGH



- 1WAY SWITCH (ONE GANG) @ 900MM HIGH



- CALLING LIGHT



 
- DISTRIBUTION BOARD



- SOCKET



- Emergency Light SOCKET



design.reinforce@gmail.com



+690 7974477

Project:

HINAVAAGE
Adh.Mandhoo

Island:

Adh.Mandhoo

Client:

Adh.Mandhoo Council

Client Contact:

+960 7791989

Architect:

Ahulam Ilyas

Engineer:

Kinaanath

Drawn By:

Assadh

Notes:

Date:

16th March 2025


Project No:

RD-207

Drawing No:


HI-07



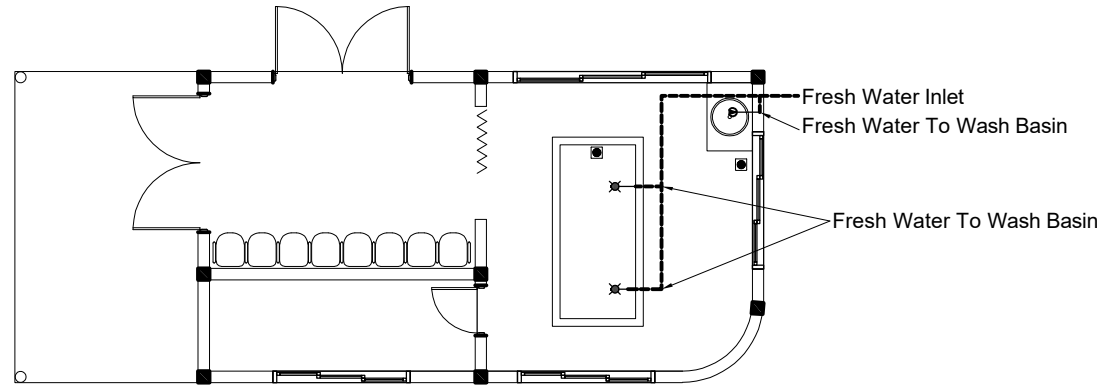

Fresh Water Layout


Scale 1:100

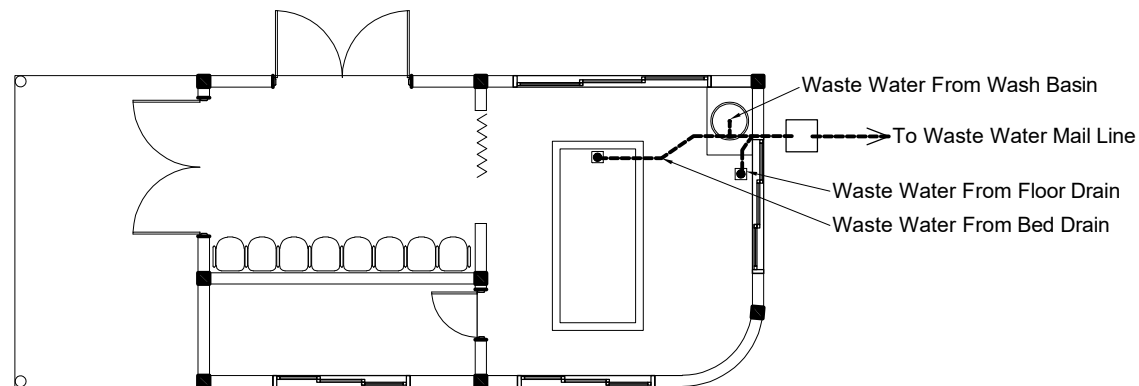

Waste Water Layout

Scale 1:100

Plumbing Symbols Key:	
SYMBOLS	DESCRIPTION
—	- Fresh Water Line (Ø25)
---	- Waste Water Line(Ø35)
⊙	- Faucet
✕	- Hand Shower
⊠	- Floor Drain

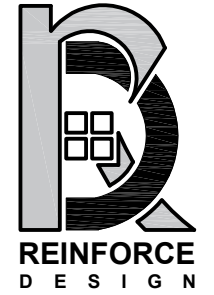

design.reinforce@gmail.com

+690 7974477

Project:
HINAVAAGE
Adh.Mandhoo

Island:
Adh.Mandhoo

Client:
Adh.Mandhoo Council

Client Contact:
+960 7791989

Architect:
Ahulam Ilyas

Engineer:
Kinaanath

Drawn By:
Assadh


Notes:

Date:
16th March 2025


Project No:
RD-207

Drawing No:

HI-08

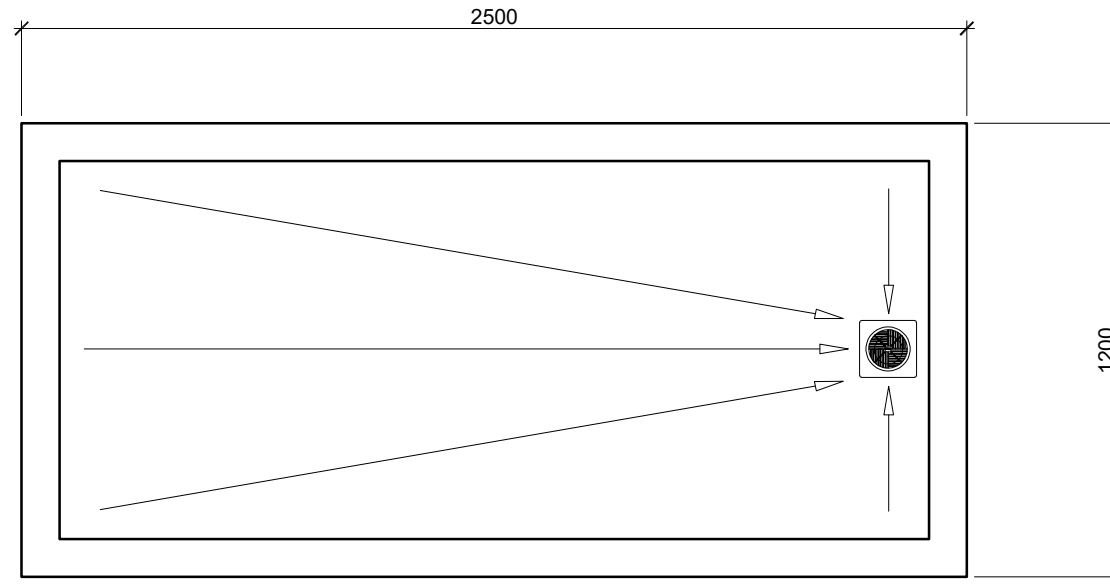

Plan

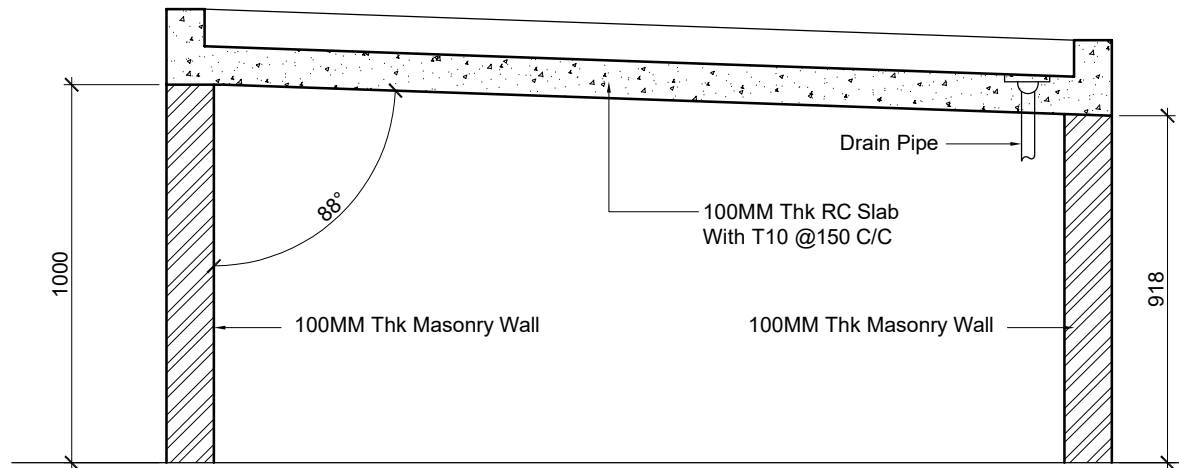

Section

Hinavaa Bed Detail

Scale 1:20



design.reinforce@gmail.com

+690 7974477

Project:
HINAVAAGE
Adh.Mandhoo

Island:
Adh.Mandhoo

Client:
Adh.Mandhoo Council

Client Contact:
+960 7791989

Architect:
Ahulam Ilyas

Engineer:
Kinaanath

Drawn By:
Assadh

Notes:

Date:
16th March 2025

Project No:
RD-207

Drawing No:

HI-09

